




- Legend:**
- Planning Application Boundary
 - Module Unit
 - fence
 - gate (6m wide)
 - transformer station (28 pcs.)
 - gravel road (3.5m width)
 - Public Footpath
 - Tree
 - Temporary Construction Compound
 - Switch Gear

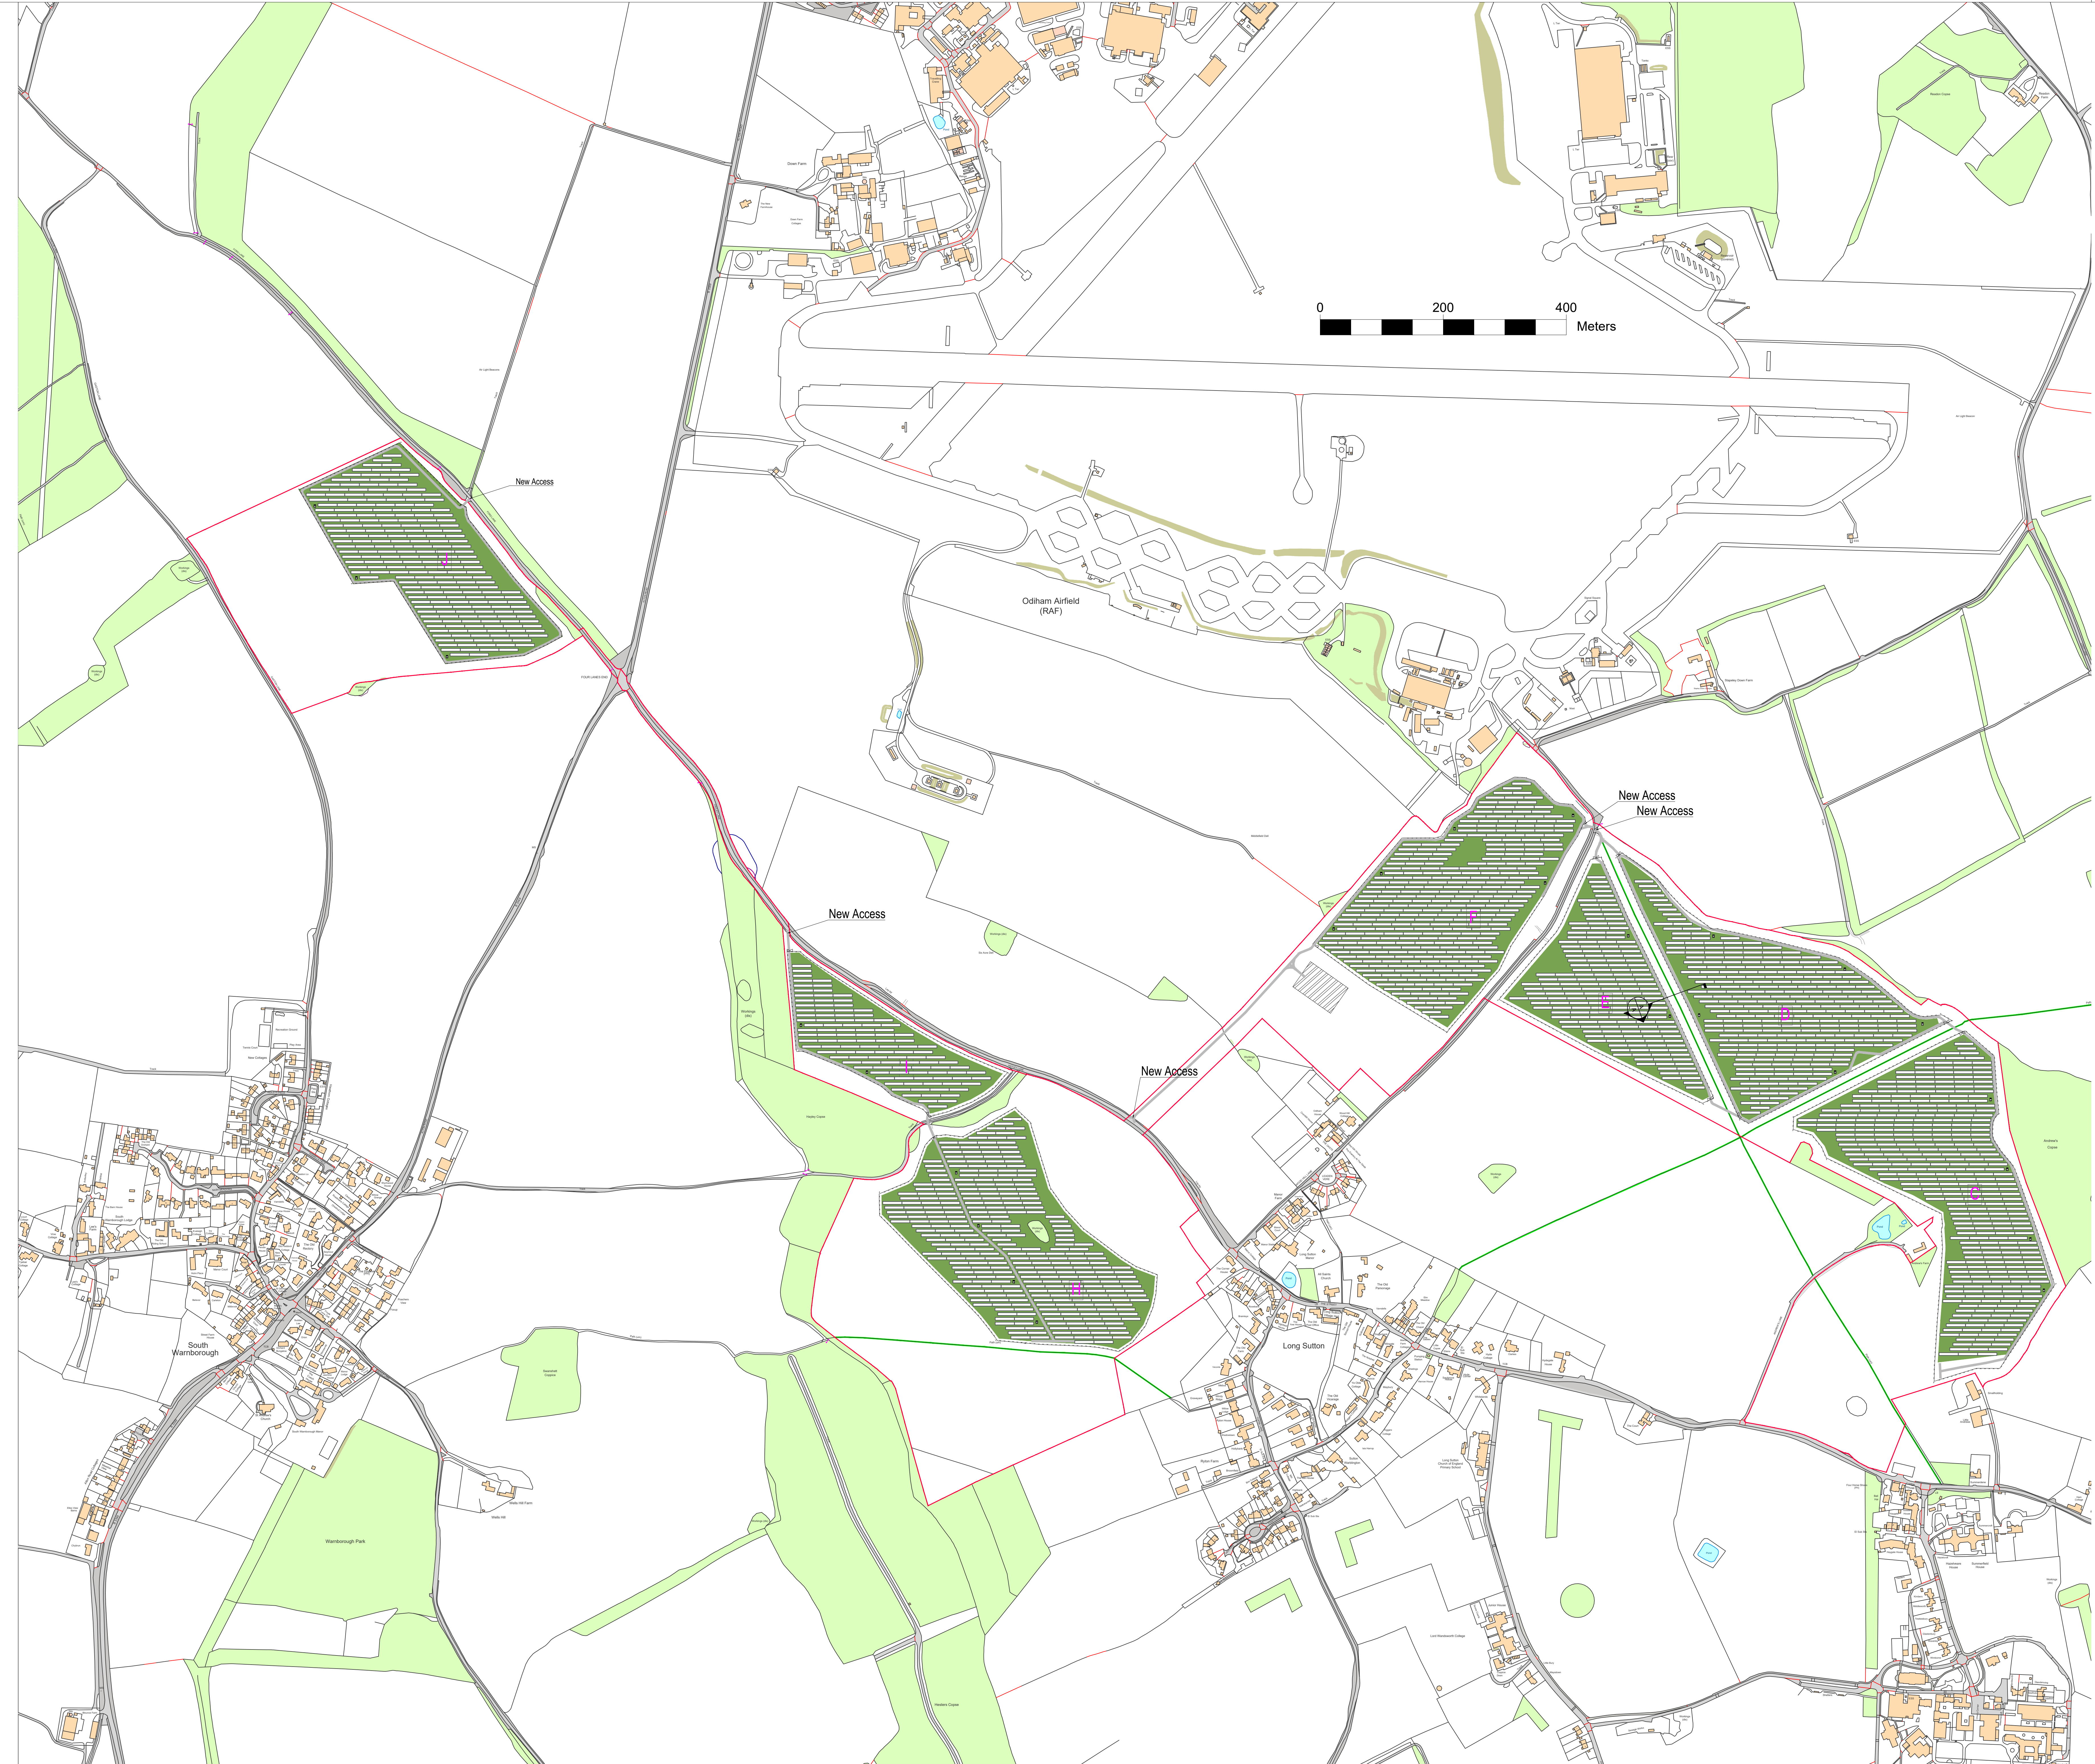

Note: distance between rows is depending on slope of site.

BayWa r.e.

BayWa r.e. Solar Projects GmbH
Arabellstrasse 4 | 81925 München, Germany
Tel.: +49 (0) 89 383030-0 | www.baywa-re.com

Project: **Fleet Solar Farm UK PV Power Plant**

Client: **Fleet Solar Ltd**

Date	Name	Planning Period:	Scale
Drawn: 24.03.2022	gly	Post Submission	1:3,500
Changed: 12.06.24	JRT		
Checked: 07.09.24	apf		
Drawing Title: 01_module layout 1_3500			Format: A0
File Name: BWre21-FFM_PD_V19.dwg			